


Luminaire Schedule

Symbol	Qty	Label	Arrangement	LMF	Lum. Lumens	Lum. Watts	Part Number
	9	CPY-FLAT-13L	SINGLE	1.000	12825	91	CPY250-B-DM-F-13L-UL-WH-57K-HZ

Calculation Summary: 1.00 LLF

Label	Units	Avg	Max	Min	Avg/Min	Max/Min
All Calc Points	Fc	0.82	34.1	0.0	N.A.	N.A.
Gas Canopy	Fc	40.11	50	31	1.29	1.61
Property Line	Fc	0.29	3.7	0.0	N.A.	N.A.

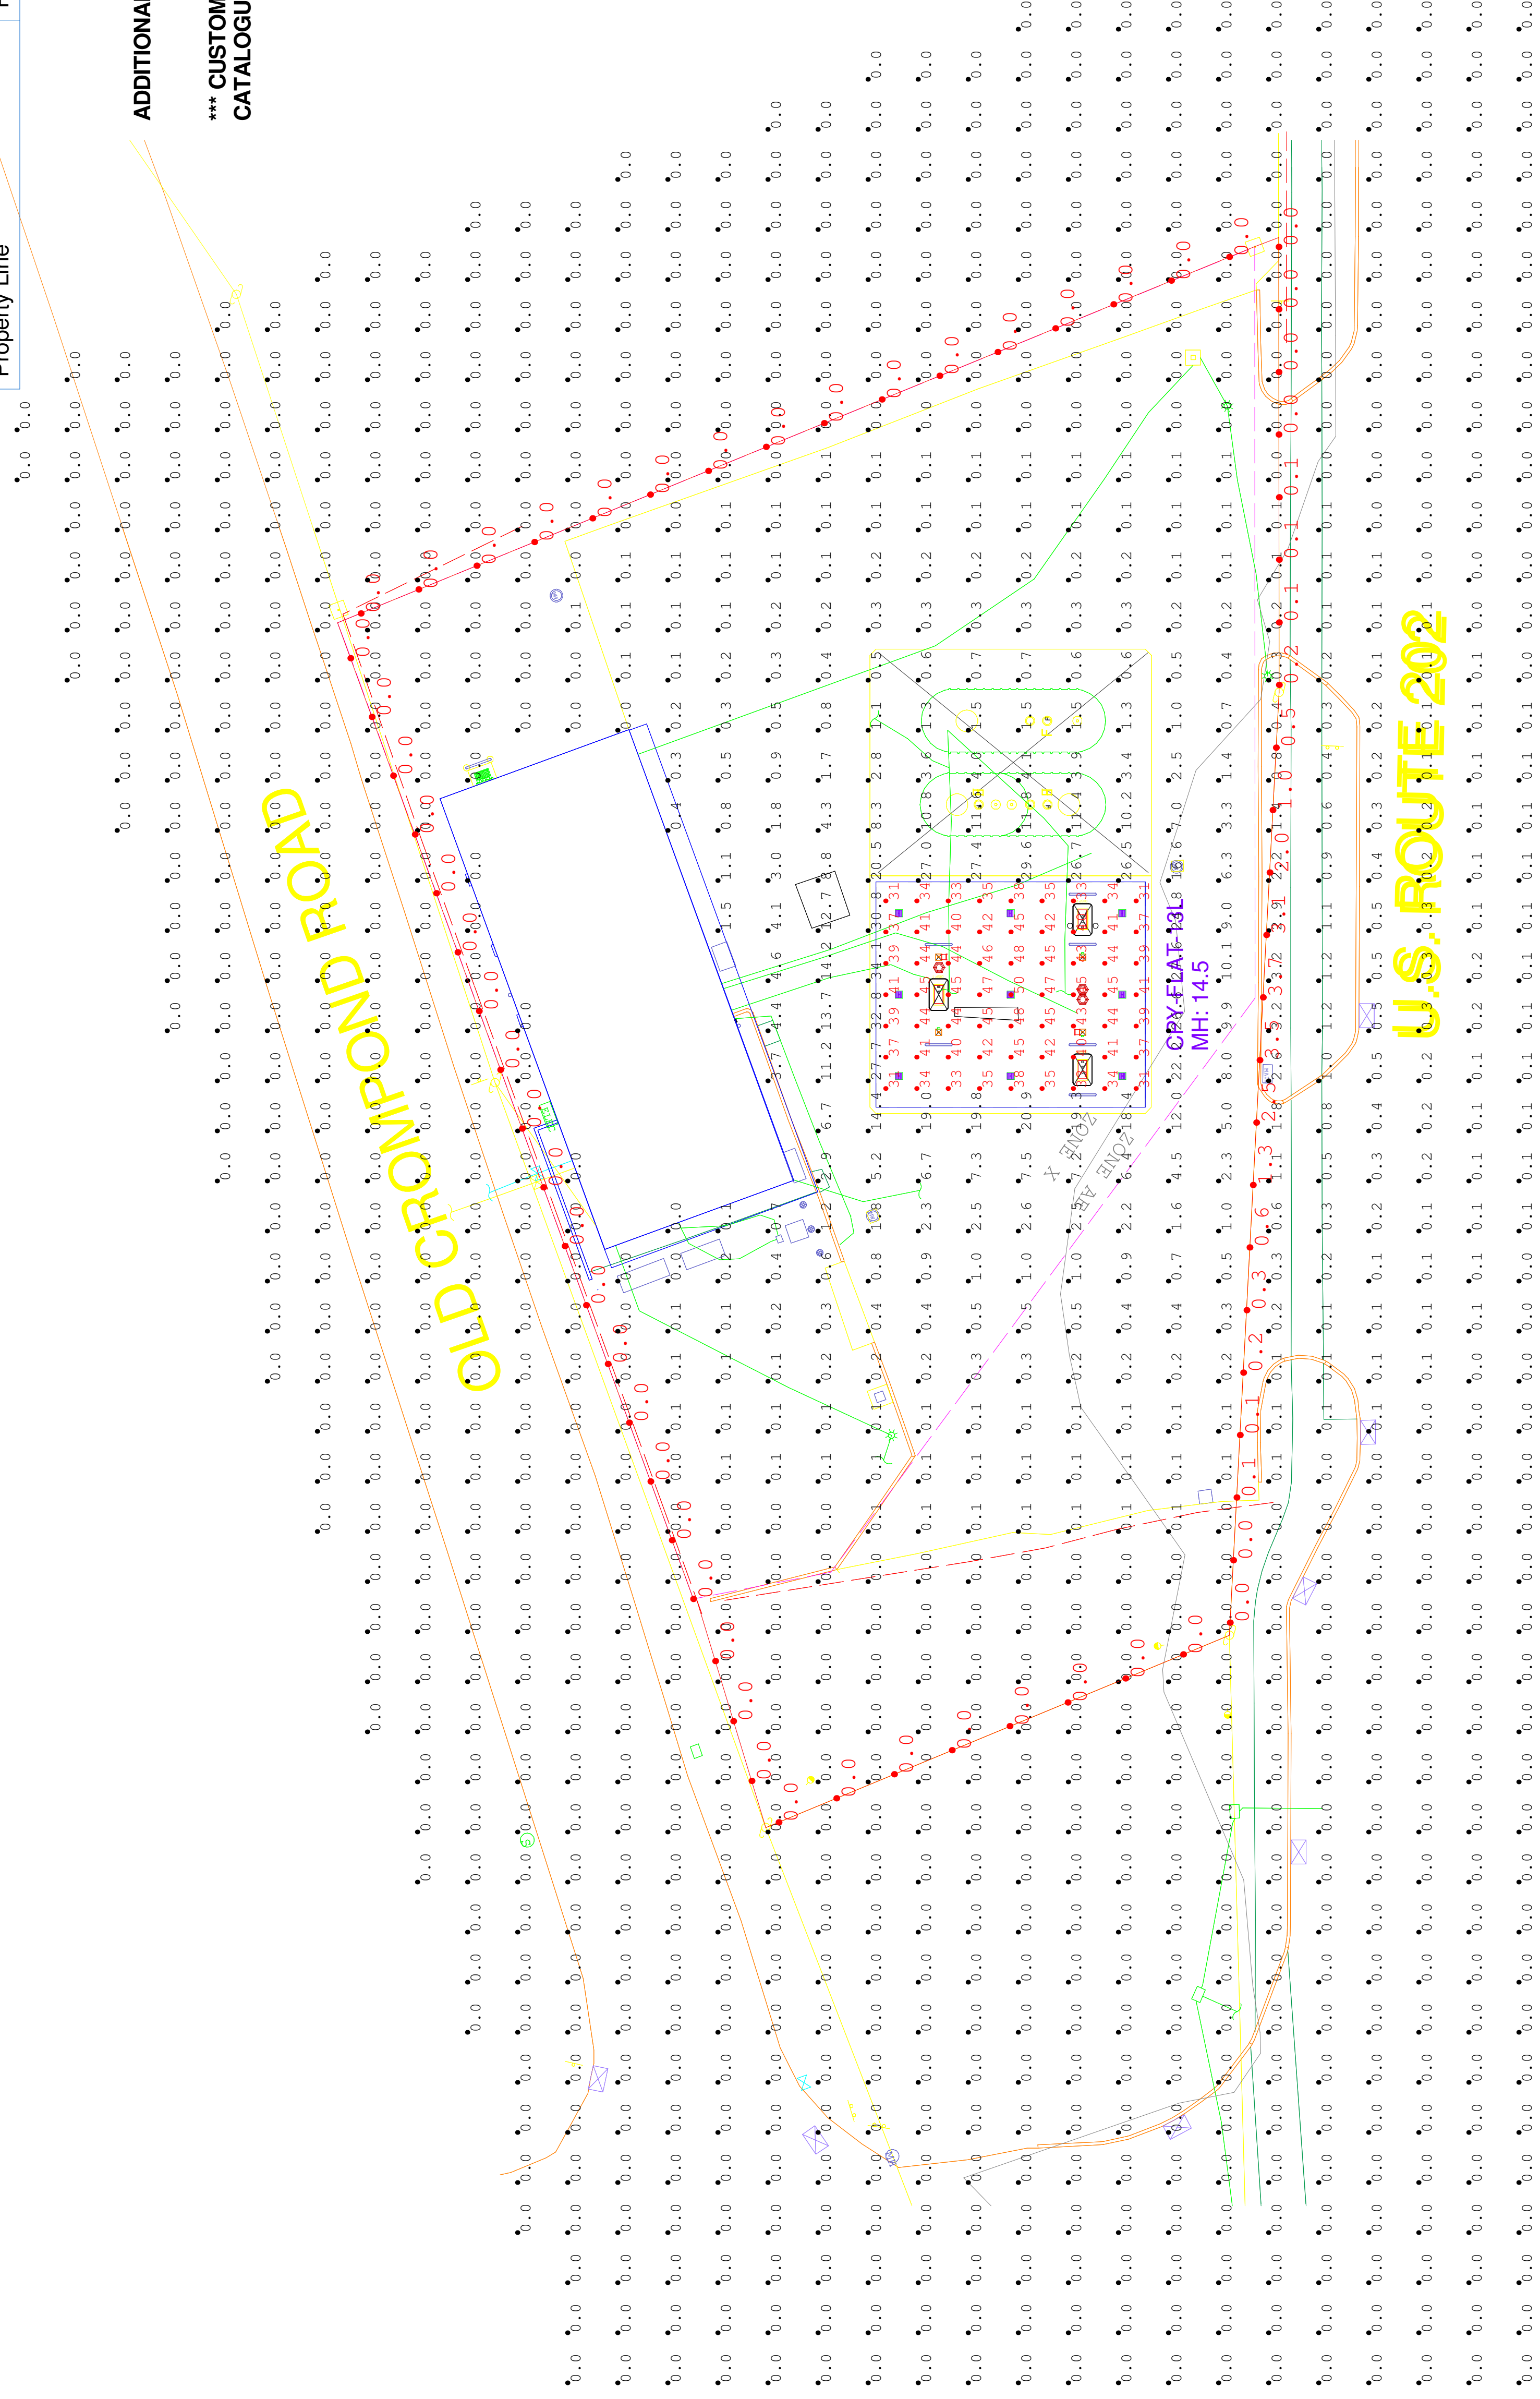

ADDITIONAL EQUIPMENT REQUIRED:

***** CUSTOMER TO VERIFY ORDERING INFORMATION AND CATALOGUE NUMBER PRIOR TO PLACING ORDER *****

illumination results shown on this lighting design are based on project parameters provided to Cree Lighting. Cree Lighting is not responsible for conditions. Actual project conditions offering from these design parameters may affect field results. Cree Lighting is not responsible for compliance with any applicable electrical, lighting, or energy code.

CREE LIGHTING
 A COMPANY OF IDEAL INDUSTRIES, INC.
 9201 Washington Ave., Racine, WI 53406 https://creelighting.com (800) 226-6800

Project Name: 7-Eleven #38912 3451 Crompond Rd Yorktown Heights, NY - EXT
 SR-36678
 Case #: 00507582
 Footcandles calculated at grade
 Filename: 711-211004YHNYBAFR2.A

Layout By:
 Collin Witherow
 Date: 8/25/2022
 Scale 1" = 16'
 0 32 64

BOM: Complete Part Description
 09 CPY250-B-DM-F-13L-UL-WH-57K-HZ